


# LAND PATTERN RECOMMENDATIONS

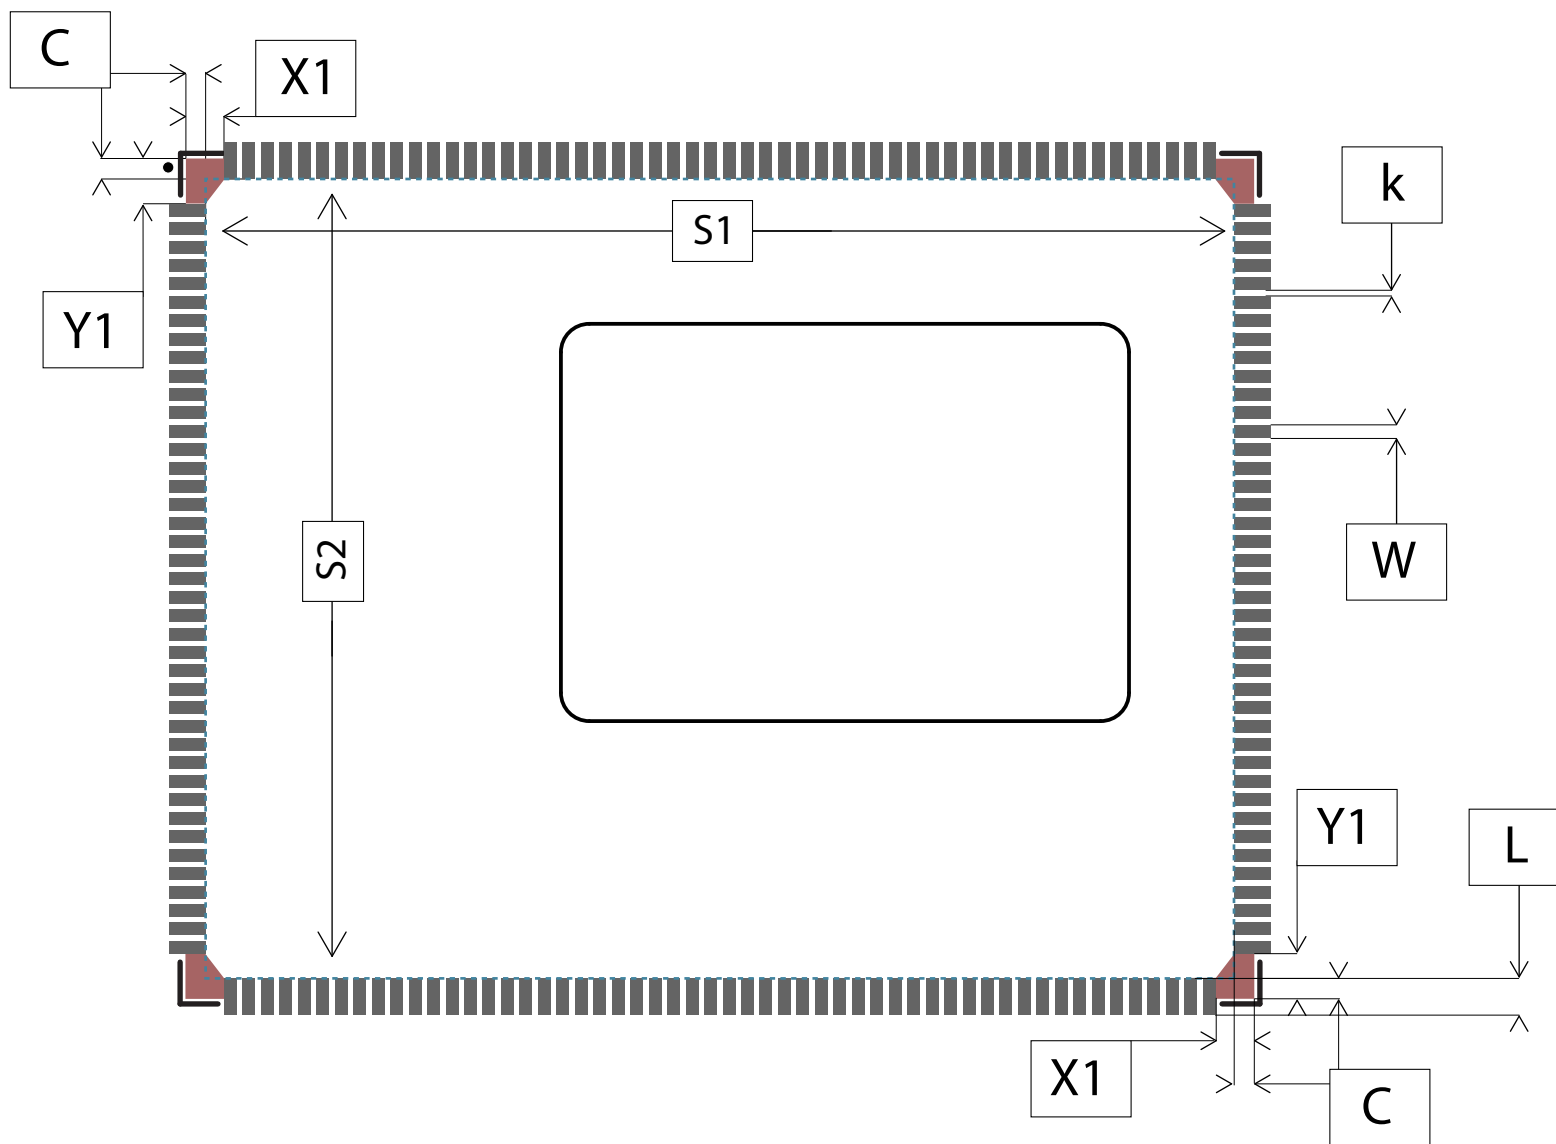

Inside <S1-S2> square keepout area  
only the following elements are allowed:

- Ground vias
- Ground copper
- Power planes



TITLE	SAMA7G54 SOM DIMENSIONS (in mm)			Drawn by : R C R
Pads :	190		Drawing No.:	SAMA7G54 SOM POD
Body :	38 x 30 x 3.13	mm	REV.:	B3
Pads Pitch :	0.65	mm	Date:	08/09/2023
Package Code :	L9B			