


LAND PATTERN RECOMMENDATIONS

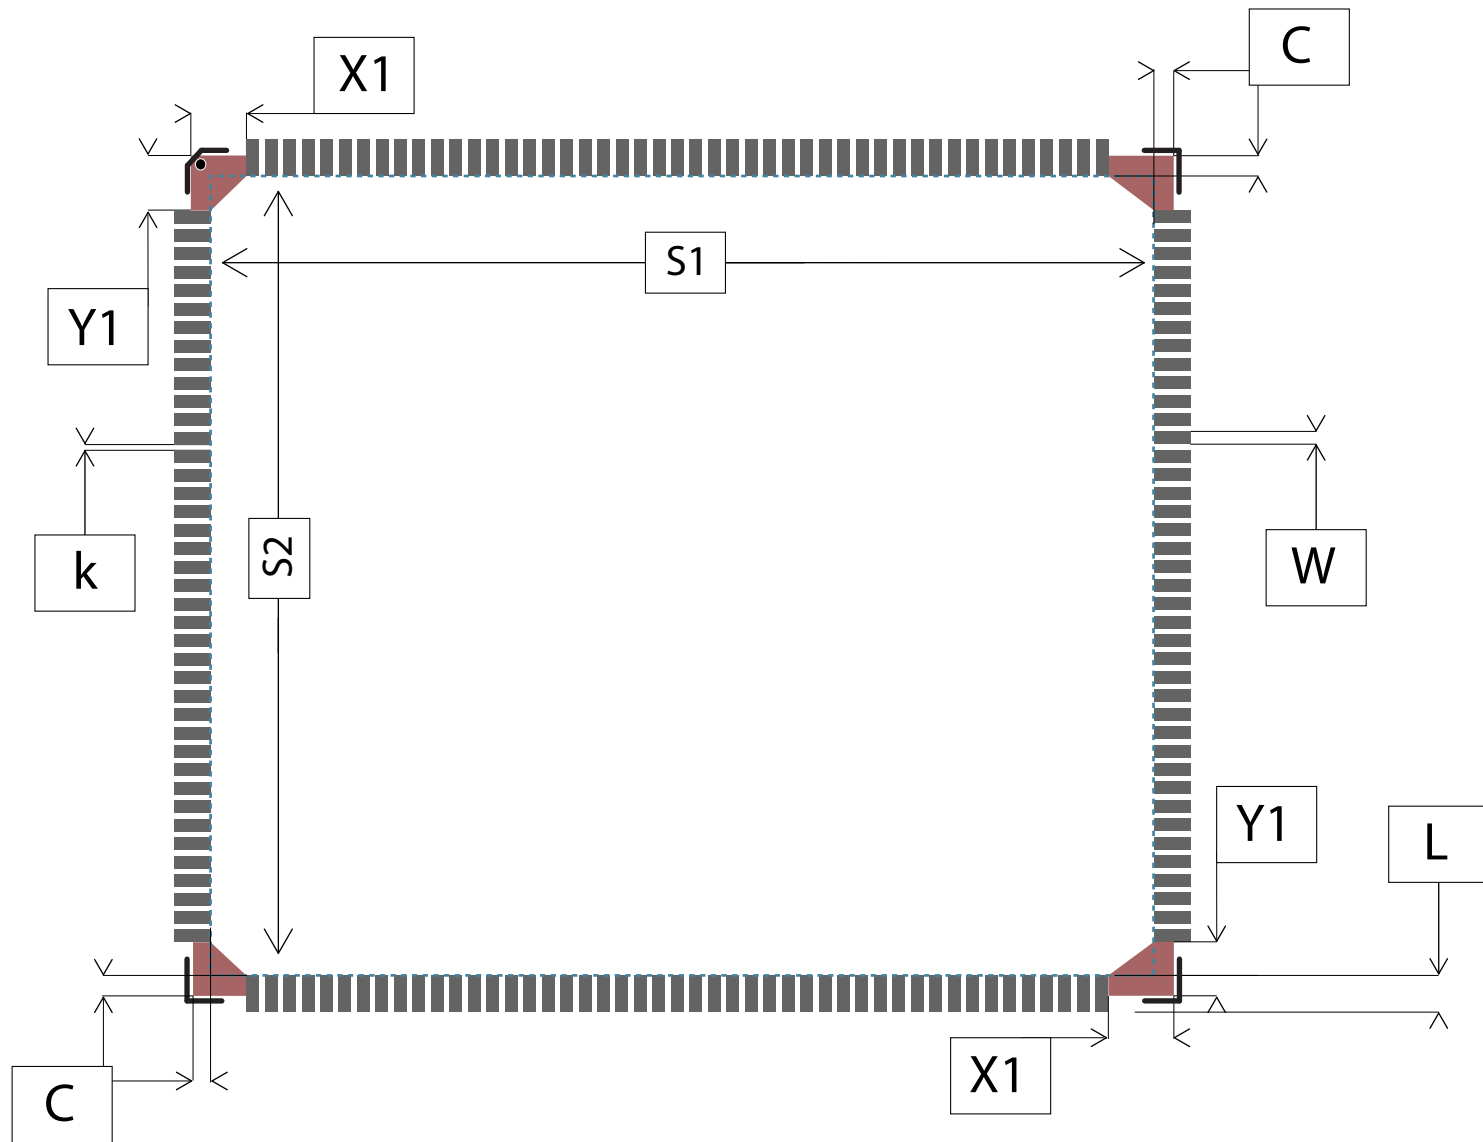

Inside <S1-S2> square keepout area
only the following elements are allowed:

- Ground vias
- Ground copper
- Power planes



TITLE	SAM9X75 SOM DIMENSIONS (in mm)			Drawn by : R C R
Pads :	174		Drawing No.:	SAM9X75 SOM POD
Body :	35 x 30 x 2.8	mm	REV.:	B2
Pads Pitch :	0.65	mm	Date:	10/10/2023
Package Code :	M4B			