


# LAND PATTERN RECOMMENDATIONS

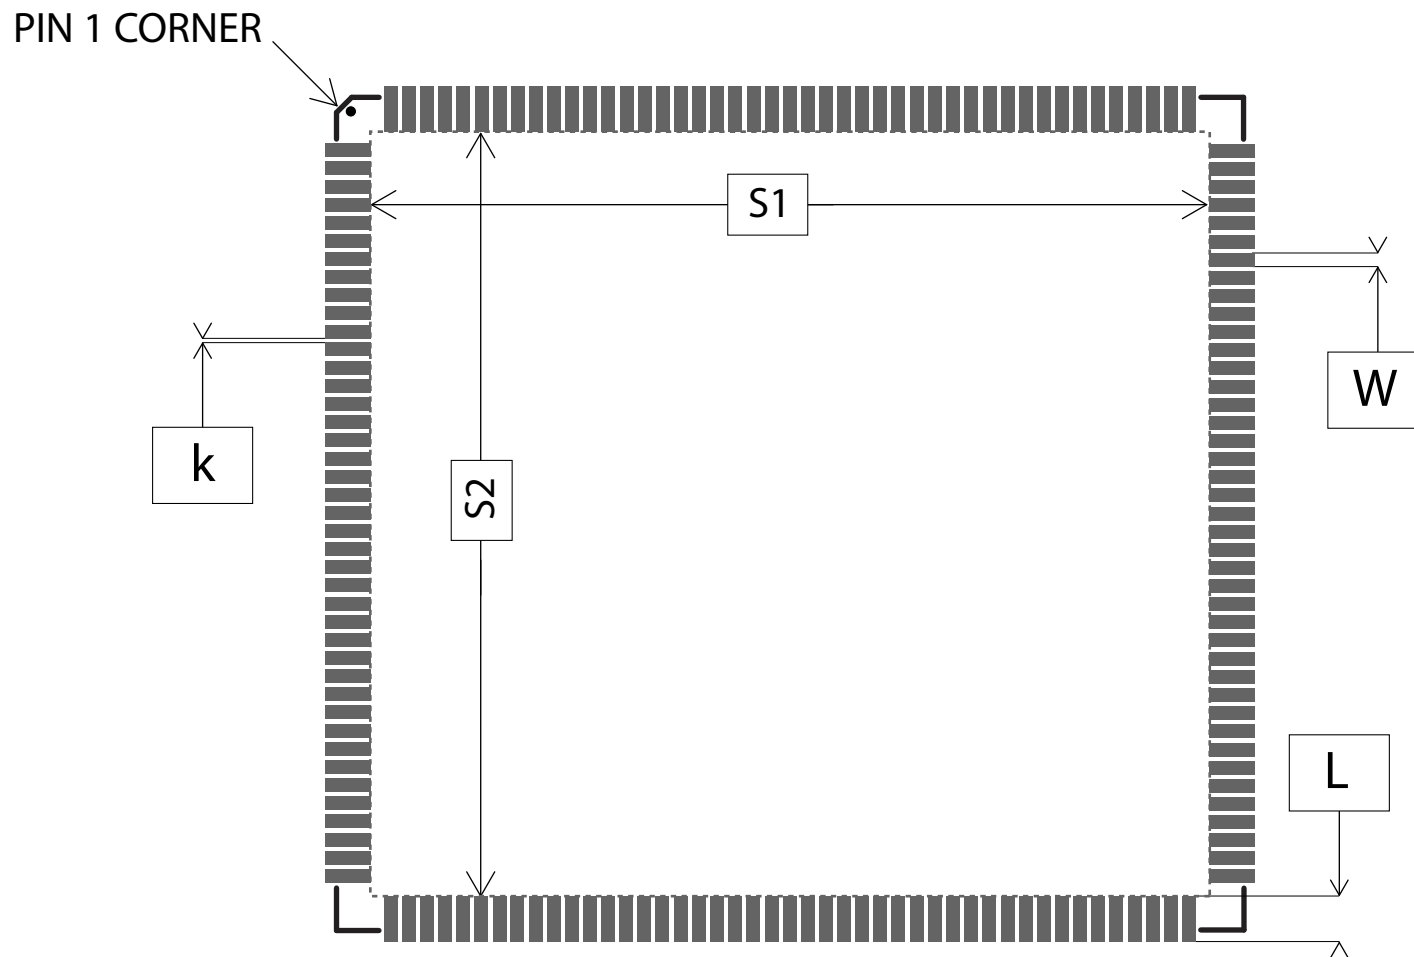

Inside <S1-S2> square, keepout area  
only the following elements are allowed:

- Ground vias
- Ground copper
- Power planes



TITLE	SAMA5D27-SOM1 DIMENSIONS			Drawn by : RCR
Pads :	176		Drawing No.:	SAMA5D27-SOM1_POD
Body :	40 x 38 x 2.75	mm	REV.:	B
Body (w/ option)	40 x 38 x 6.49	mm	Date:	12/28/2022
Pads Pitch :	0.8	mm		